


HVAC PLAN

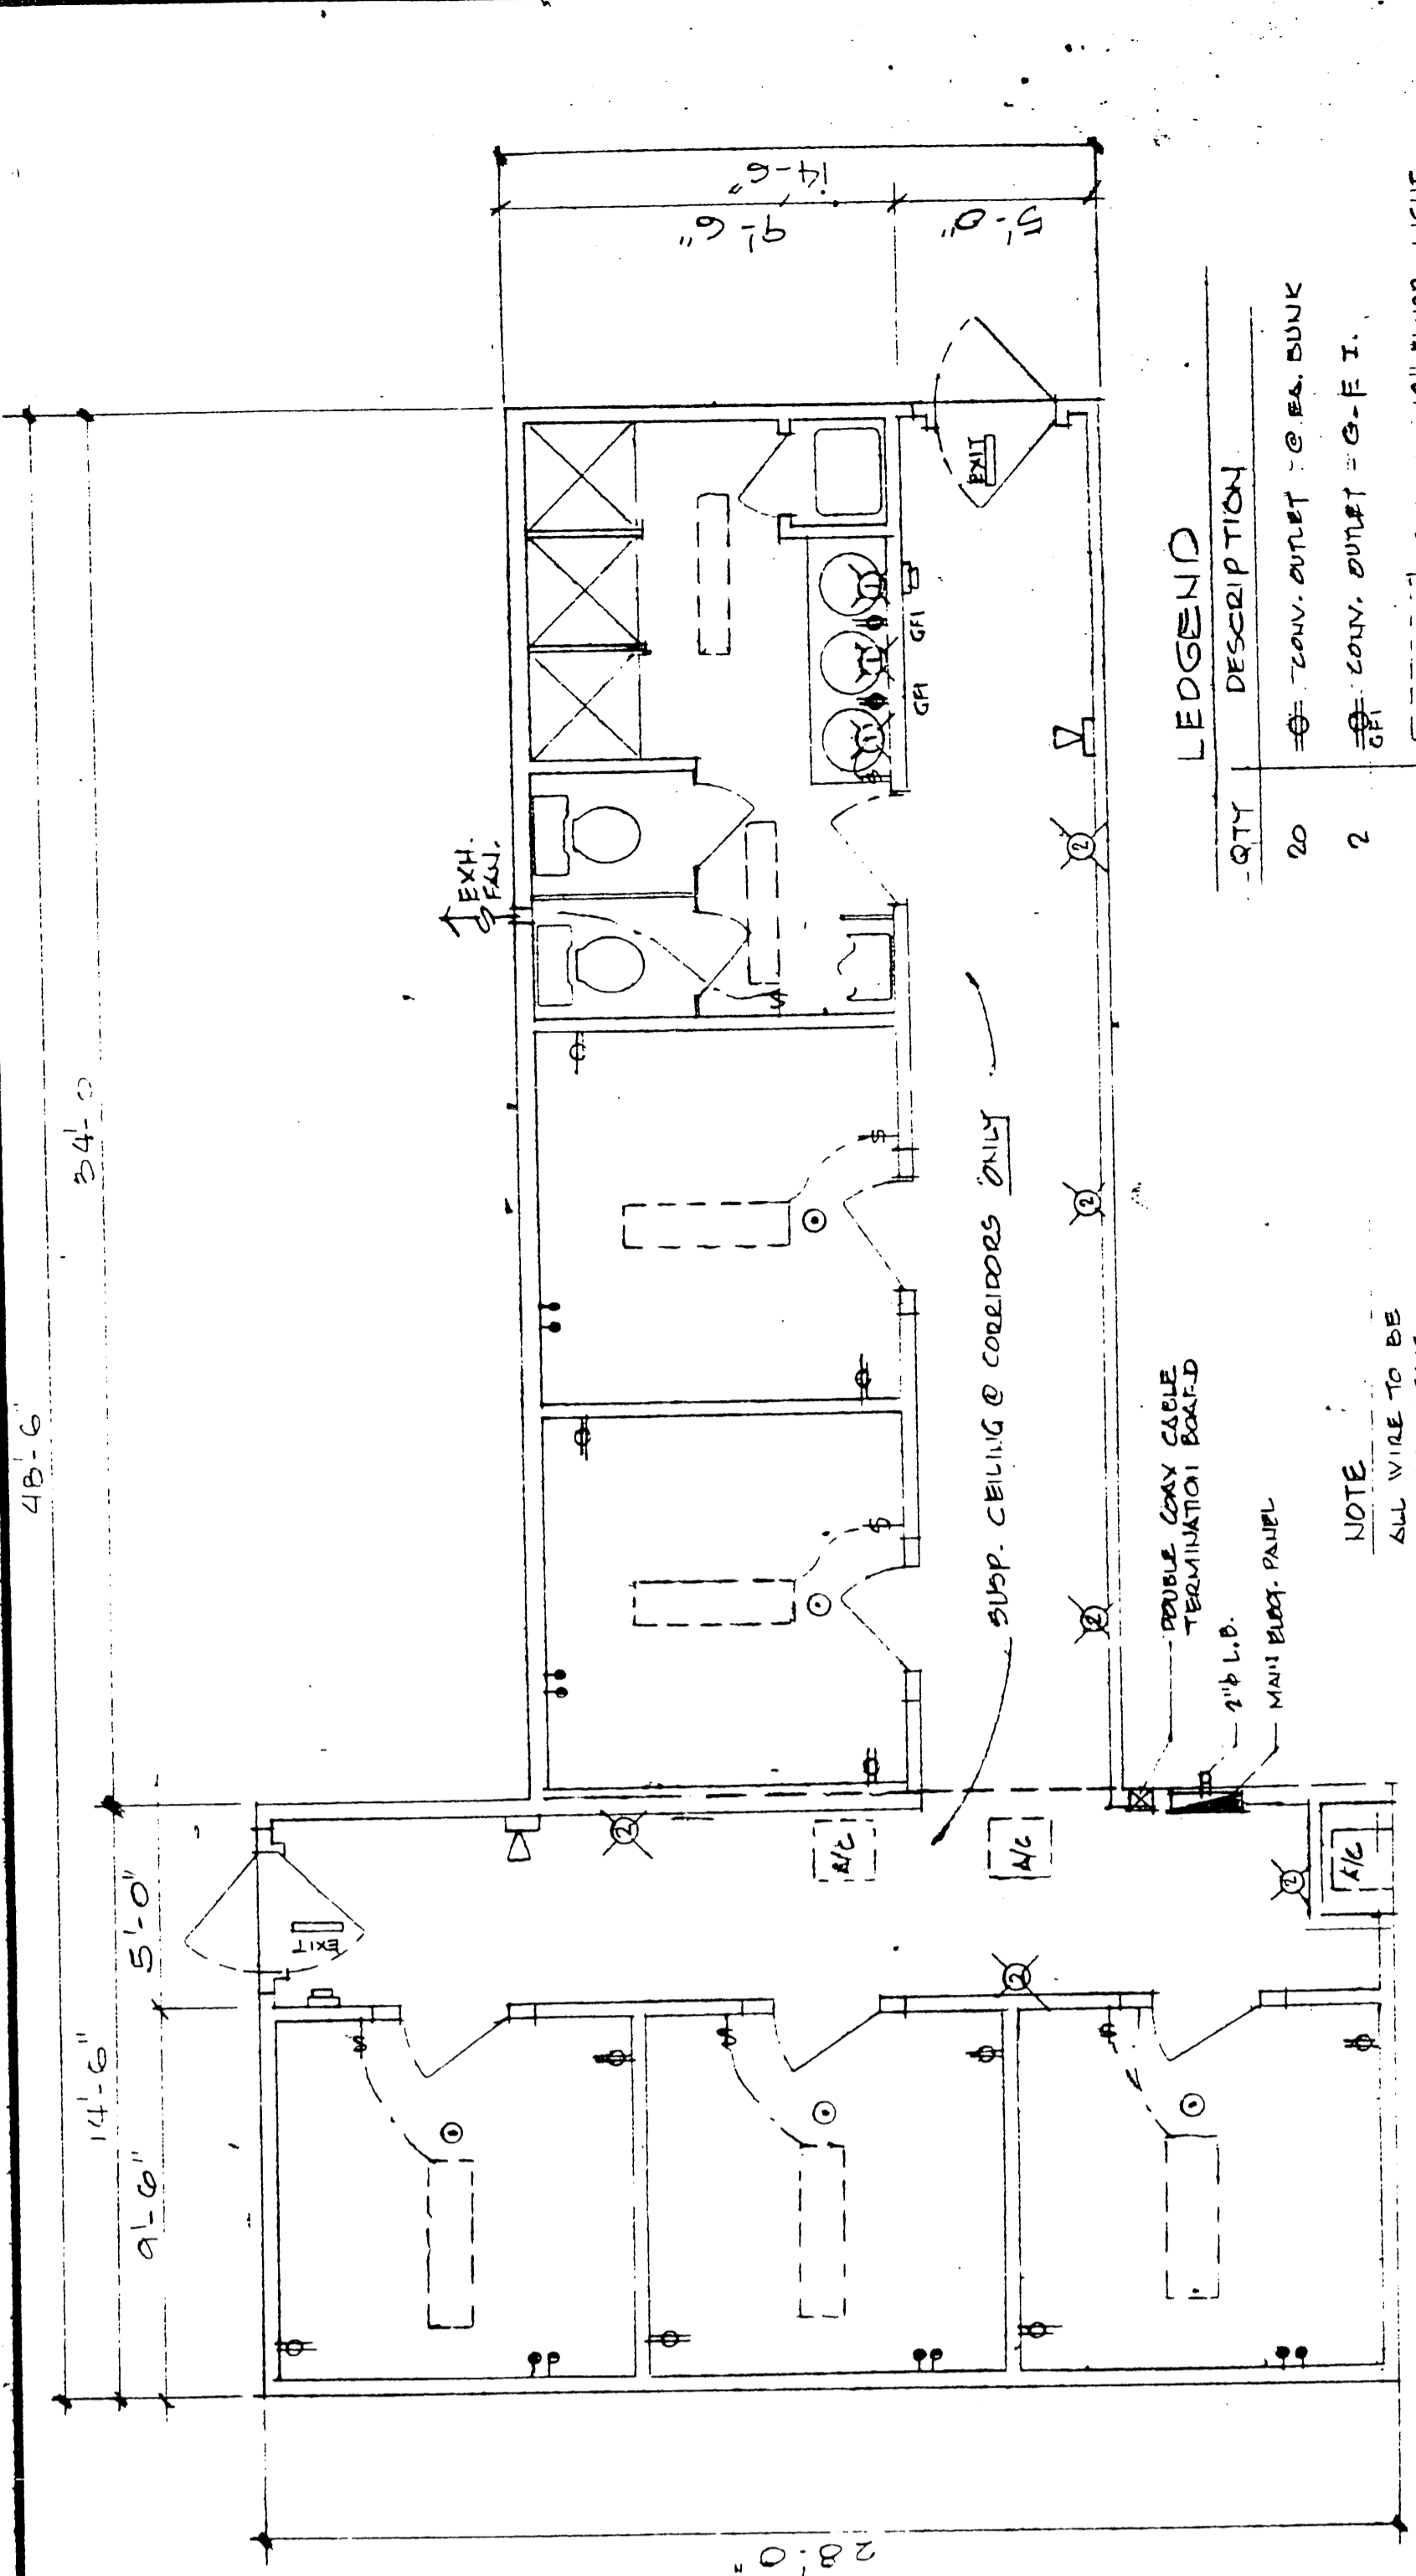


ELECTRICAL PLAN

LEGEND

QTY	DESCRIPTION
20	TELEPH. OUTLET @ EA. DESK
2	CONV. OUTLET - G-F I.
7	2-PHASE 48" FLOOR LIGHT
7	SWITCH
5	PHONE CABLE WALL OUTLETS
2	SHIF. GENERAL ALARM. DEP STATION (12 V. DC)
2	MANUAL ALARM PULL STATION
5	SUPP. ALARM
3	LABORATORY WALL LIGHTS
6	CORRIDOR WALL LIGHT
2	EXIT LIGHTS

NOTE
ALL WIRE TO BE
MACHINE CABLE

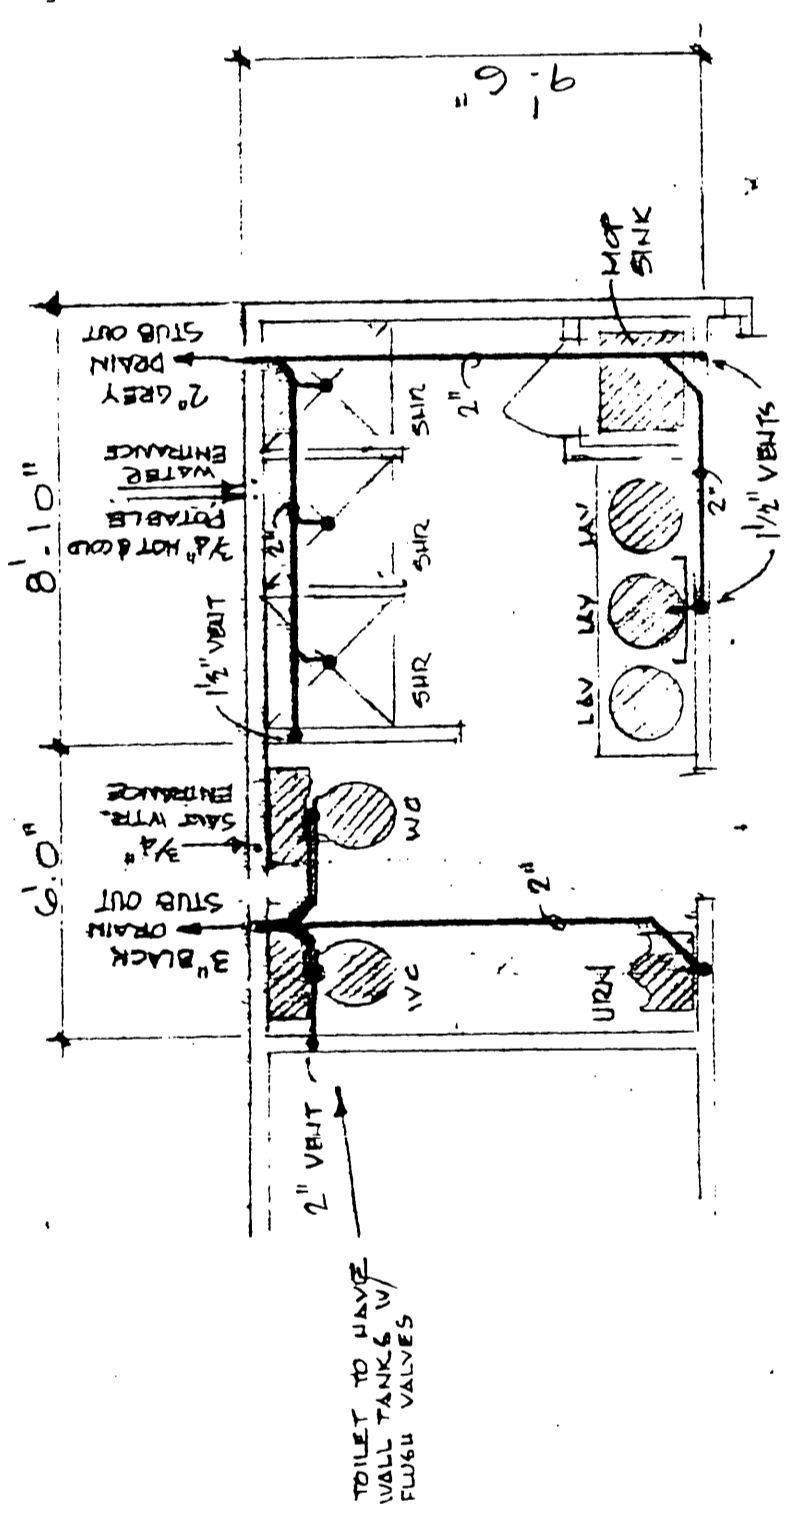

PLUMBING FLOOR PLAN

NOTES

REVISIONS	BY	DATE

INTERNATIONAL BUILDING SYSTEMS
 P.O. BOX 258889 HOUSTON, TEXAS 77215-8889 (713) 991-2000

DRAWN BY: RZ	APPROVED:
DATE: 5.14.97	CHECKED BY:
CHECKED BY:	DATE:
DATE:	SCALE:

TITLE: ELECTRICAL/PLUMBING/HVAC PLANS
 DRAWING NO. D-788-A2
 CLIENT: FAIRFIELD INDUSTRIES
 LOCATION OF PROJECT: M/V GEOTIDE

JOB NO.	SHEET NO.	OF
---------	-----------	----